

Neff Hall - HVAC Upgrades Phase 2

ADDENDUM #02

TO CONTRACT DOCUMENTS FOR: Project #CP – 231442

ADVERTISEMENT DATE: March 13, 2024

PREPARED FOR: The Curators of the University of Missouri

CONSULTANT: Klingner and Associates, P.C.
3622 Endeavor Avenue, Suite 117
Columbia, MO 65201
(573) 355-5988

The contract documents for the above noted project and the work covered thereby and herein modified.

GENERAL INFORMATION:

- 1) None.

PROJECT MANUAL:

- 1) None.

DRAWINGS:

- 1) Drawing Sheet E105 Cover Sheet, **REVISE** Office 1, Office 3, Office 3A, and Office 3C thermostat power supply from AH15 CTRL-1 to RIB-1.
- 2) Drawing Sheet E105 Cover Sheet, **REVISE** Office 10, Office 10A, and Office 10C thermostat power supply from AH5 CTRL-1 to RIB-1.
- 3) Drawing Sheet E106 Cover Sheet, **REVISE** Office 103, Office 104, Conference 105, Office 107, and Corridor C101W thermostat power supply from AH4 CTRL-1 to RIB-2.
- 4) Drawing Sheet E106 Cover Sheet, **REVISE** Lounge 108, Office 110, Office 119, Office 102, Office 121, and Office 122 thermostat power supply from AH11 CTRL-1 to RIB-2.
- 5) Drawing Sheet E107 Cover Sheet, **REVISE** Office 200A and Office 202 thermostat power supply from AH9 CTRL-1 to RIB-3.

- 6) Drawing Sheet E107 Cover Sheet, **REVISE** Office 206 and Office 208 thermostat power supply from AH6 CTRL-1 to RIB-3.

END OF ADDENDUM #02


3/11/2024 4:08:03 PM
 C:\Users\mbriggs\Documents\22MEP - Neff Hall HVAC 23-3005 - Repath_mbriggs\027.rvt

KEYNOTE LEGEND	
VALUE	DESCRIPTION
E10	RELOCATE AND REINSTALL EXISTING WIRELESS ACCESS POINT AS REQUIRED.


KLINGNER & ASSOCIATES, P.C.
 Engineers • Architects • Surveyors
 Columbia, Missouri
 3822 Endeavor Ave, Suite 117
 Burlingame, IA 50801
 573.395.5988
 www.klinger.com

© 2020 KLINGNER & ASSOCIATES P.C.
 This document shall not be used for any purpose or project for which it is not intended. Klinger & Associates P.C. and their Associates shall be held responsible for the content and any errors herein. No liability shall be assumed for any damages, losses and expenses, including attorneys fees, and costs arising out of any reliance on or reuse of this document in addition, unauthorized reproduction of this document in part or as a whole is prohibited.


REVISION HISTORY	DATE	APPR
A1 PHASE 2 ADDW 01	03/07/24	MHB
A2 PHASE 2 ADDW 02	03/13/24	MHB

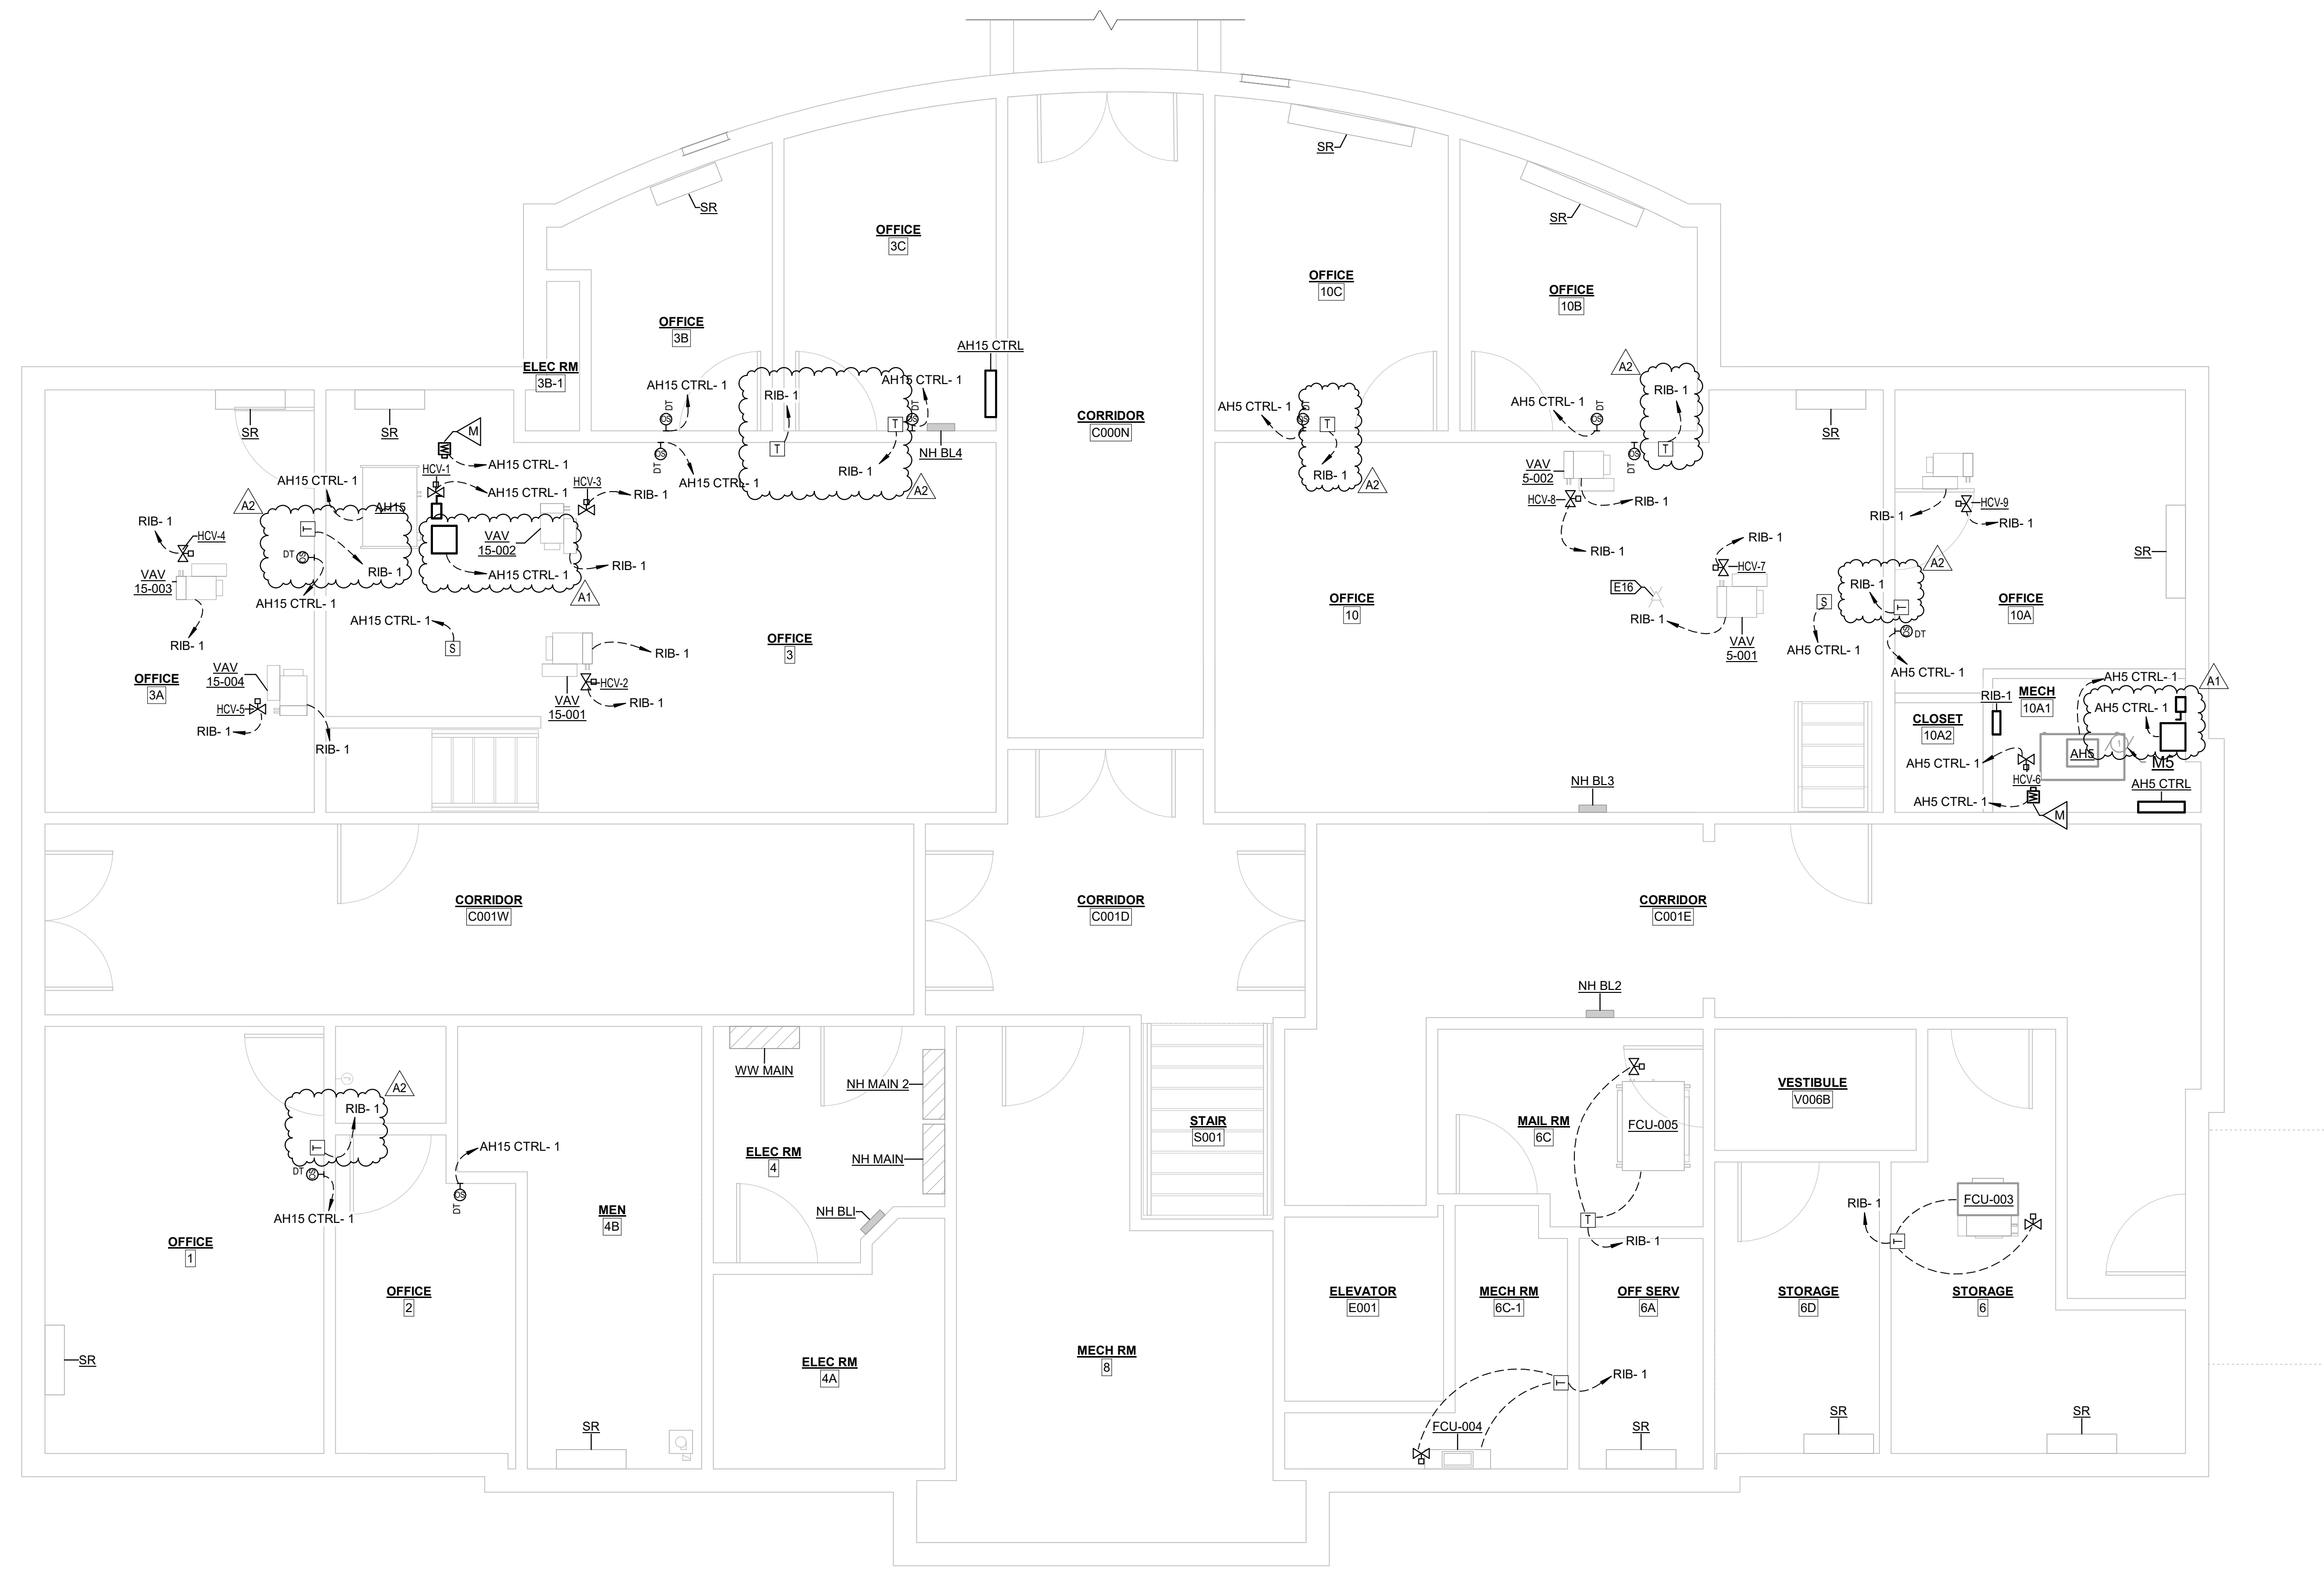

1 BASEMENT LOW VOLTAGE PLAN
 1/4" = 1'-0"

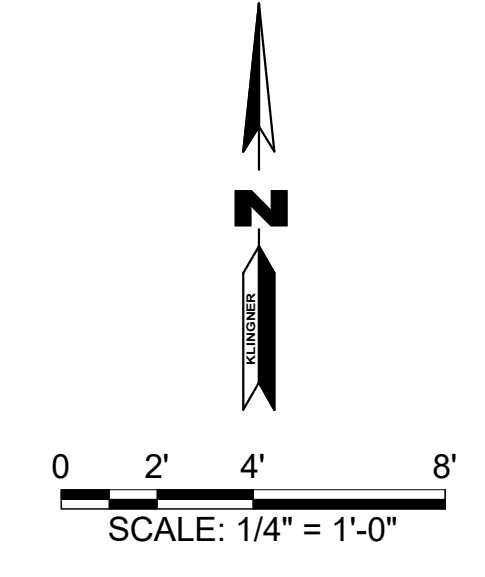

ISSUED FOR: 02/09/24
 CONSTRUCTION PHASE 2

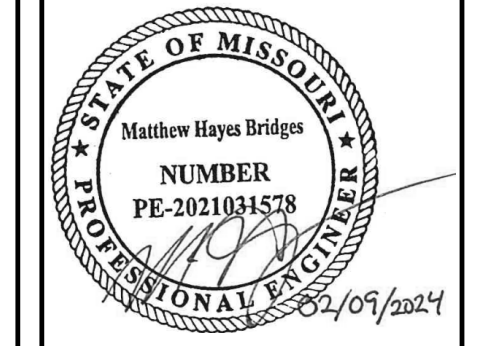

NEFF HALL - HVAC UPGRADES PHASE 2
 UNIVERSITY OF MISSOURI
 309 S 9TH STREET COLUMBIA, MO 65201

Non-Reduced Sheet Size 30" x 42"
 Full sized plans have been prepared using standard scales.
 Reduced sized plans may not conform to standard scales.


DESIGNED	MHB	DRAWN	MHB
FIELD	FIELD BOOK		
CHECKED	JAK	CHECK DATE	02/09/24
SHEET TITLE			
BASEMENT LOW VOLTAGE PLAN			
PROJECT NO. CP231442			
DRAWING ISSUED DATE: 03/07/24			
SHEET			
E105			

VALUE	DESCRIPTION
E07	FURNISH AND INSTALL NEW DUCT MOUNTED SMOKE DETECTOR ON AIR HANDLING UNIT RETURN DUCT.
E09	FURNISH AND INSTALL CARBON DIOXIDE SENSOR. FURNISH AND INSTALL COMMUNICATION WIRING BACK TO LOCAL CONTROL PANEL.

KLINGNER & ASSOCIATES, P.C.
 Engineers • Architects • Surveyors
 Columbia, Missouri
 3822 Endeavor Ave, Suite 117
 Burlingame, IA 50801
 www.klinger.com
 Quincy, IL, Columbus, IL, Peoria, IA
 573.955.5988

REVISION	DATE	APPROVED
A1	03/07/24	MHB
A2	03/13/24	MHB

ISSUED FOR: **02/09/24**
CONSTRUCTION
PHASE 2

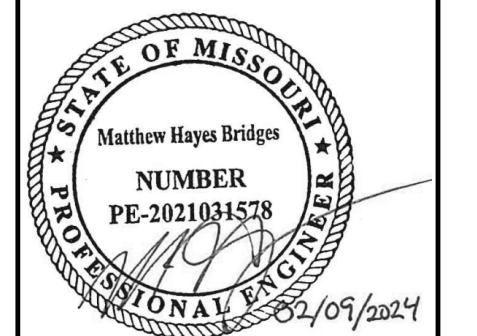

NEFF HALL - HVAC UPGRADES PHASE 2
UNIVERSITY OF MISSOURI
309 S 9TH STREET COLUMBIA, MO 65201



DESIGNED	MHB	DRAWN	MHB
FIELD	JAK	FIELD BOOK	JAK
CHECKED	JAK	CHECK DATE	02/09/24
SHEET TITLE			

FIRST FLOOR LOW VOLTAGE PLAN

PROJECT NO: CP231442
 DRAWING ISSUED DATE: 03/07/24
 SHEET


E106

1 FIRST FLOOR LOW VOLTAGE PLAN
 1/4" = 1'-0"

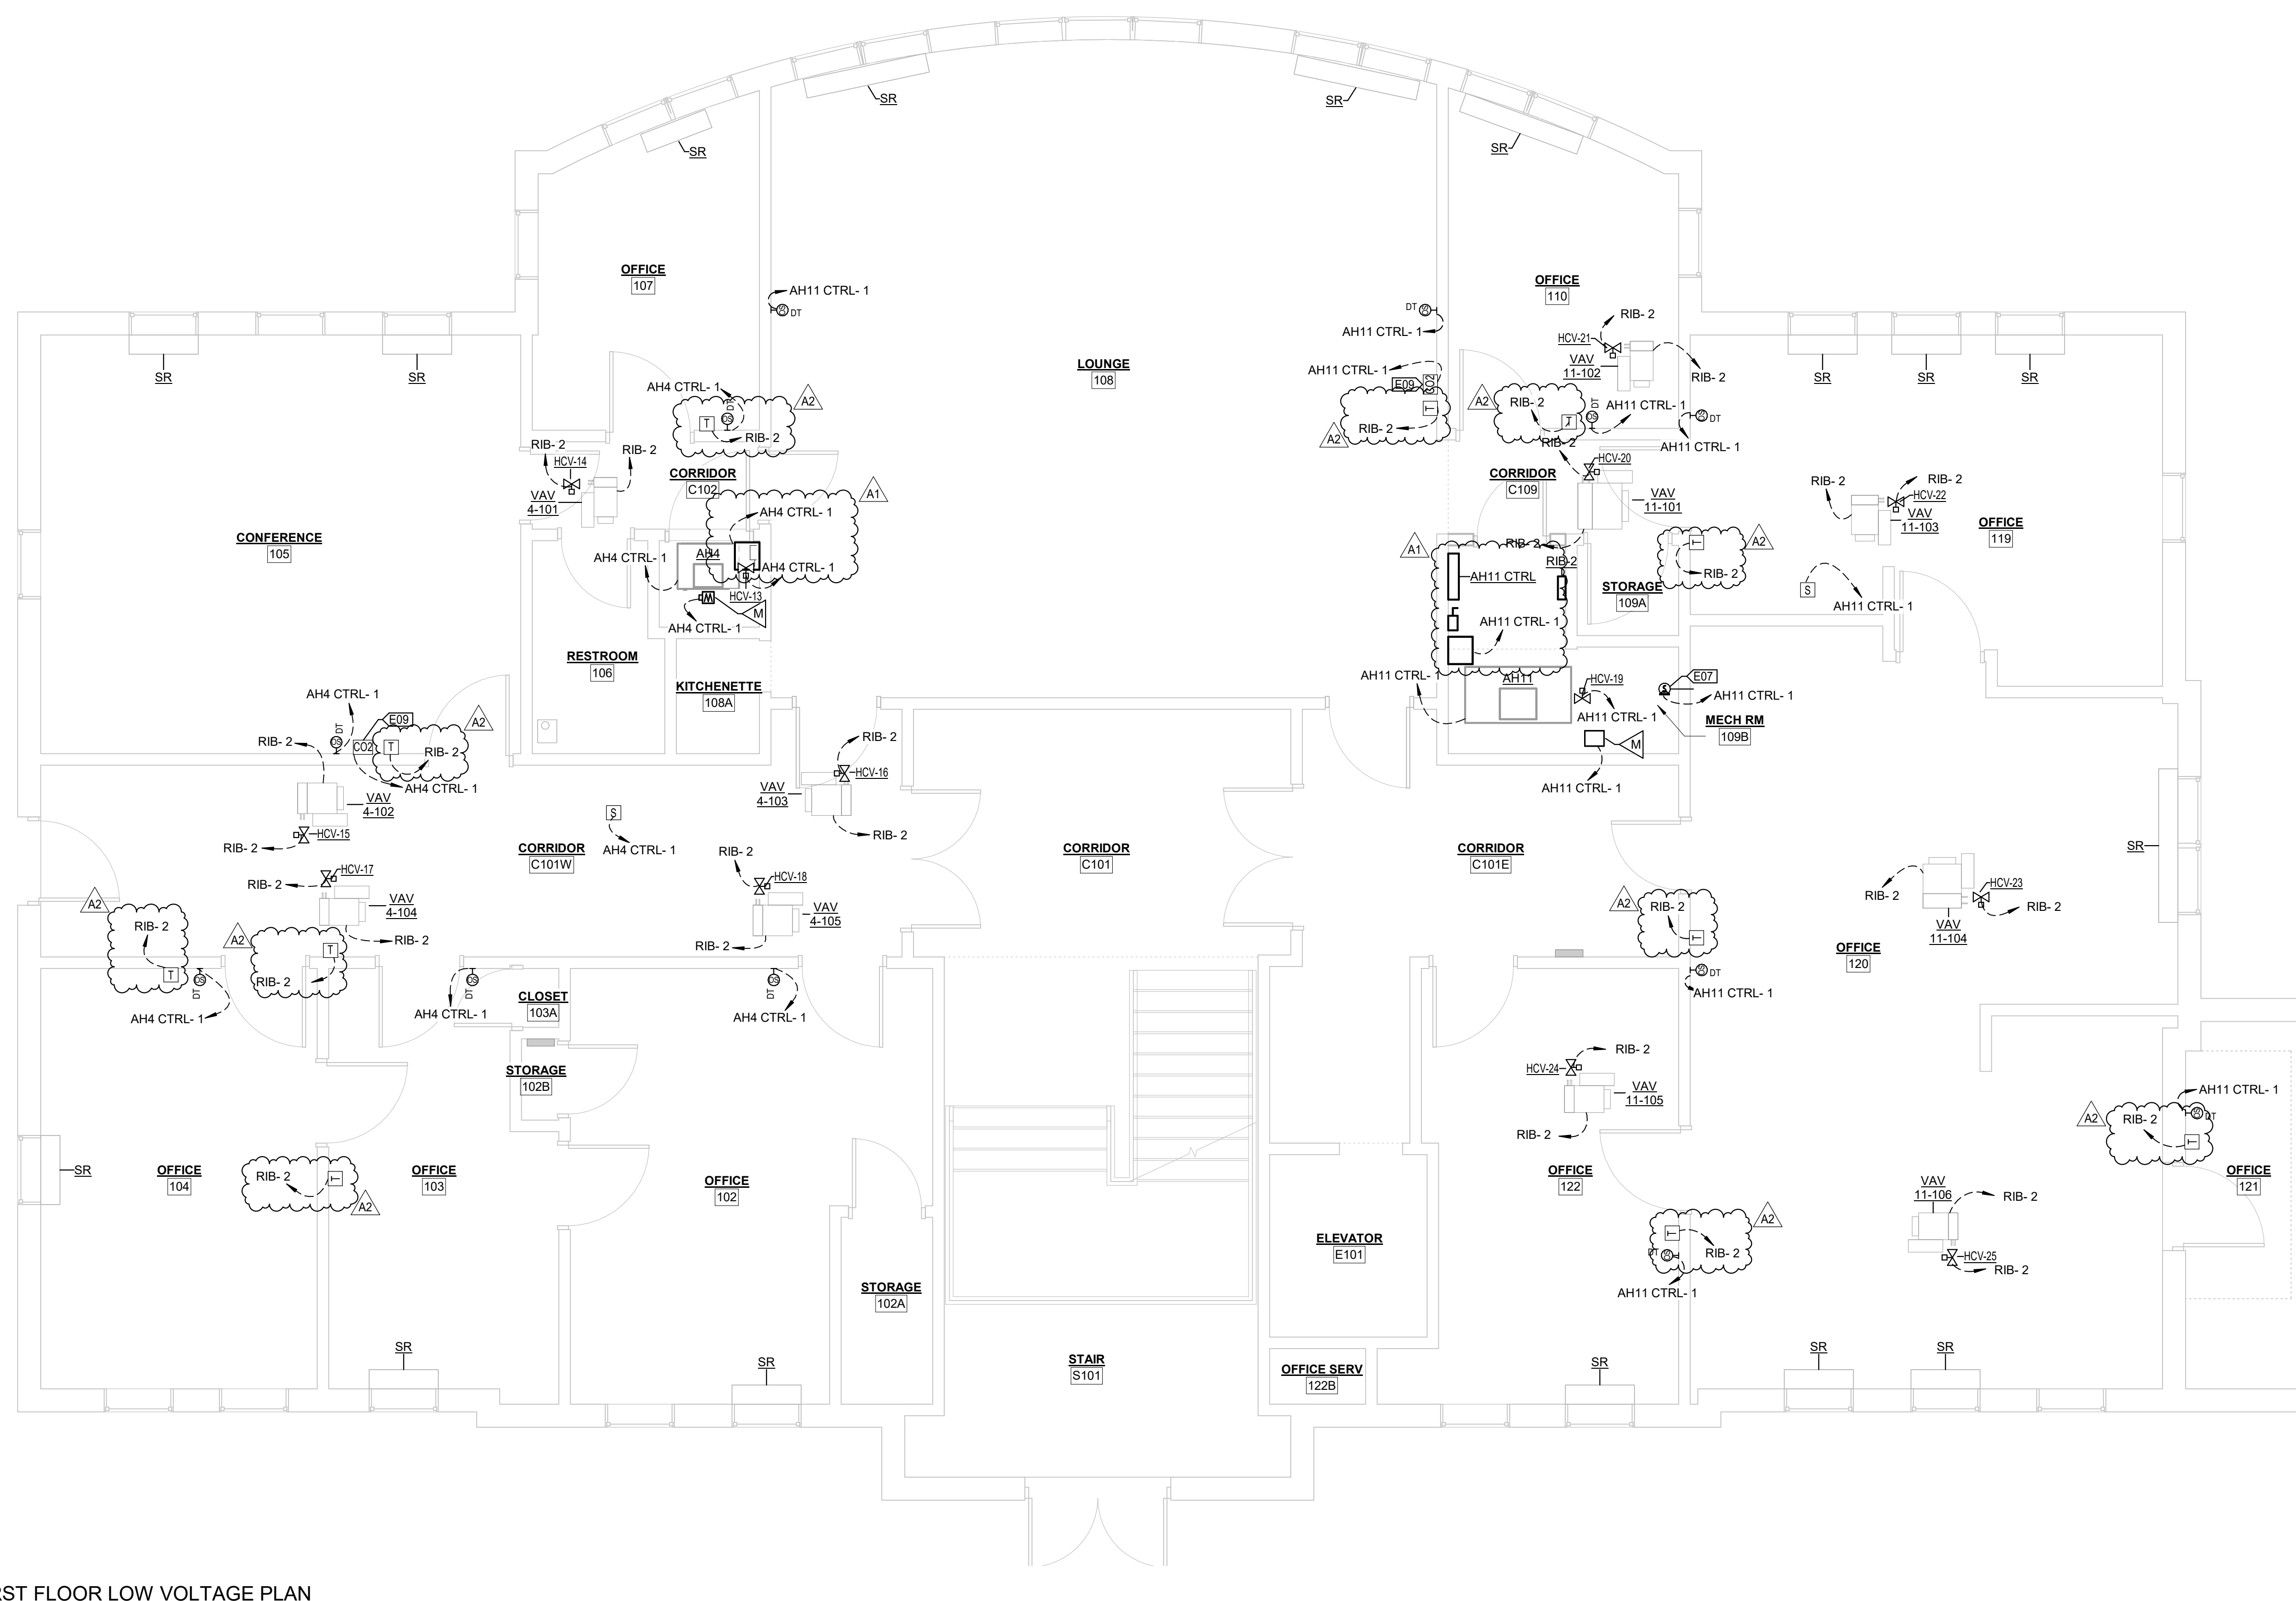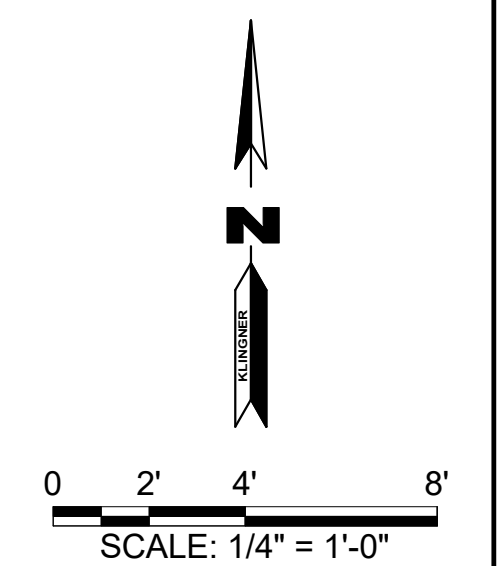


3/11/2024 4:08:03 PM
 C:\Users\mhb\Documents\22MEP - Neff Hall HVAC_25-3005 - Repath_mhb\pex\07.rvt

VALUE	DESCRIPTION
E09	FURNISH AND INSTALL CARBON DIOXIDE SENSOR. FURNISH AND INSTALL COMMUNICATION WIRING BACK TO LOCAL CONTROL PANEL.

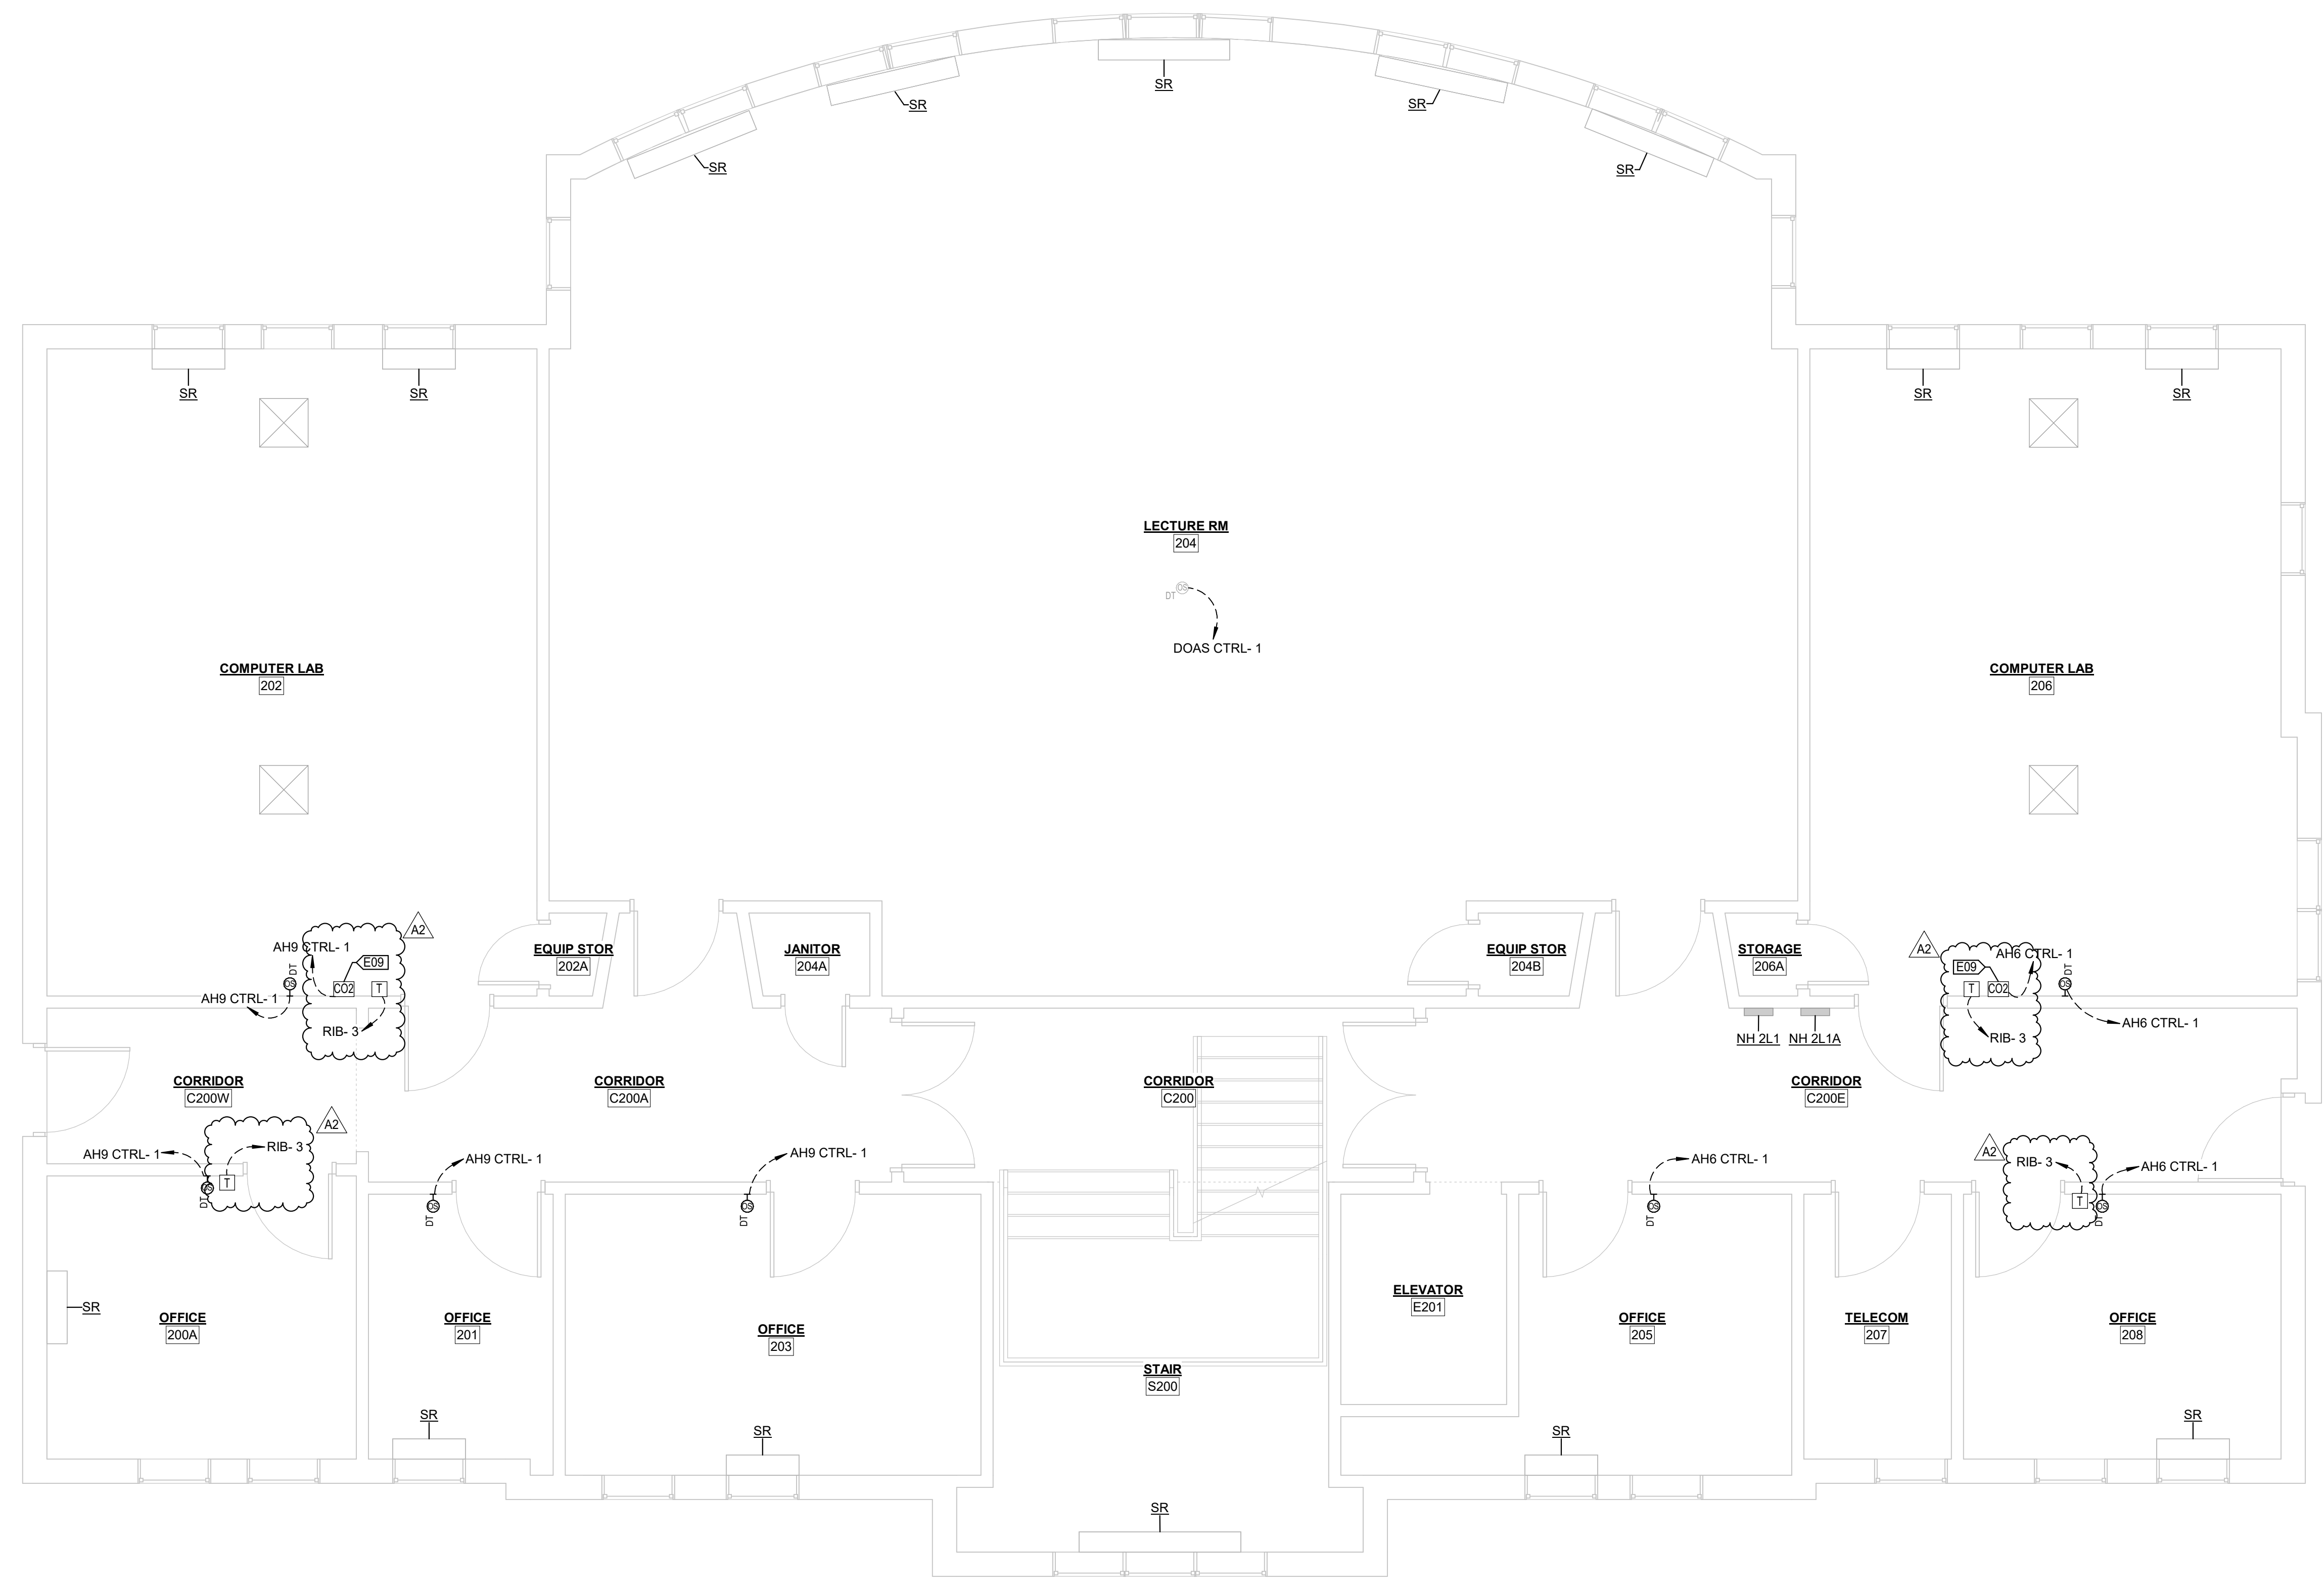

1 SECOND FLOOR LOW VOLTAGE PLAN
 1/4" = 1'-0"

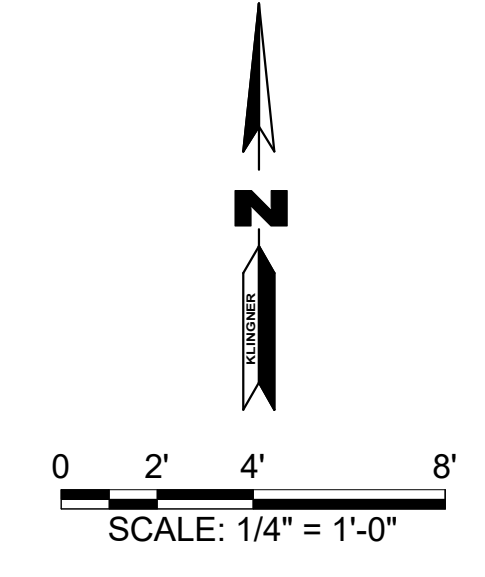


KLINGNER & ASSOCIATES, P. C.
 Engineers • Architects • Surveyors
 Columbia, Missouri
 3822 Endeavor Ave, Suite 117
 573.955.5988
 www.klinger.com
 Quincy, IL, Columbus, IL, St. Louis, MO, Burlington, IA, Davenport, IA, Hannibal, MO

© 2020 KLINGNER & ASSOCIATES P.C.
 The document shall not be used for any purpose or project for which it is not intended. Klinger & Associates P.C. and their Associates shall be held responsible for the client and third parties from all claims, damages, liabilities, losses and expenses, including attorneys fees, and costs arising out of such misuse or reuse of this document. In addition, unauthorized reproduction of this document in part or as a whole is prohibited.

NO.	DESCRIPTION	DATE	APPR.
A1	PHASE 2	02/13/24	MHB
A2	ADD# 02		

ISSUED FOR: **02/09/24**
CONSTRUCTION PHASE 2

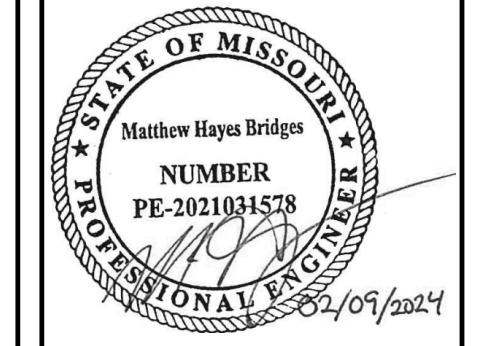

NEFF HALL - HVAC UPGRADES PHASE 2
UNIVERSITY OF MISSOURI
309 S 9TH STREET COLUMBIA, MO 65201

Non-Reduced Sheet Size 30" x 42"
 Full sized plans have been prepared using standard scales.
 Reduced sized plans may not conform to standard scales.

DESIGNED	MHB	DRAWN	MHB
FIELD	MHB	FIELD BOOK	
CHECKED	JAK	CHECK DATE	02/09/24
SHEET TITLE			
SECOND FLOOR LOW VOLTAGE PLAN			
PROJECT NO. CP231442			
DRAWING ISSUED DATE: 02/09/24			
SHEET			
E107			